
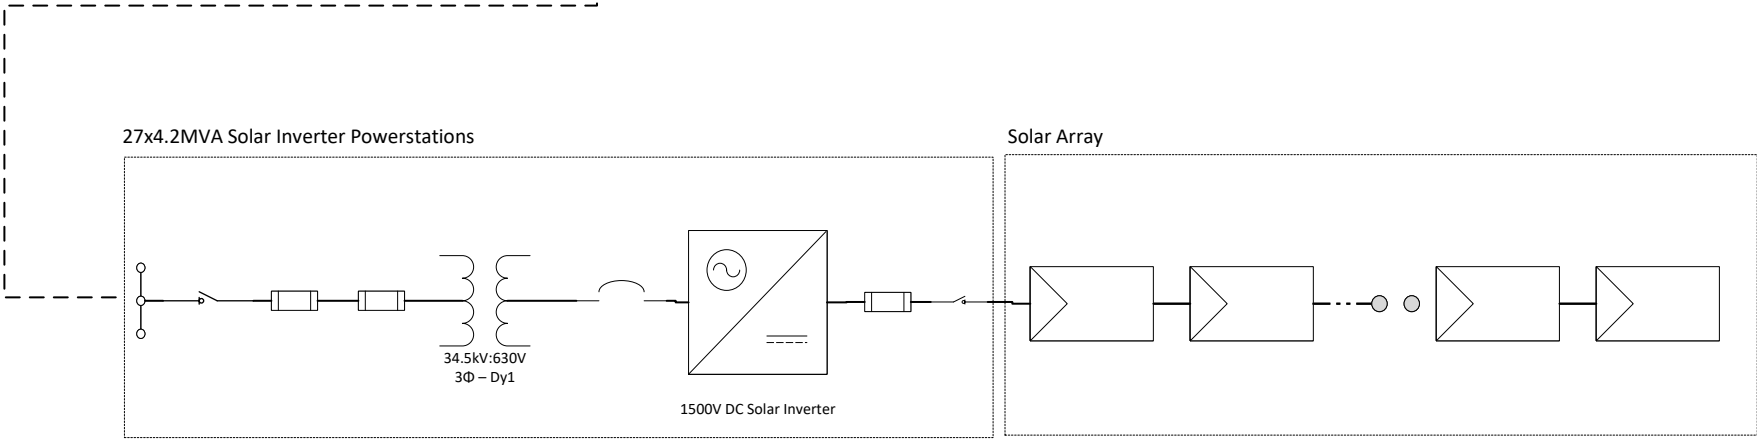


Foxtrot Solar
System Summary (Totals):

AC Nameplate Capacity:	100MW
Inverters:	27x4.2MVA
Transformers:	27x4.2MVA

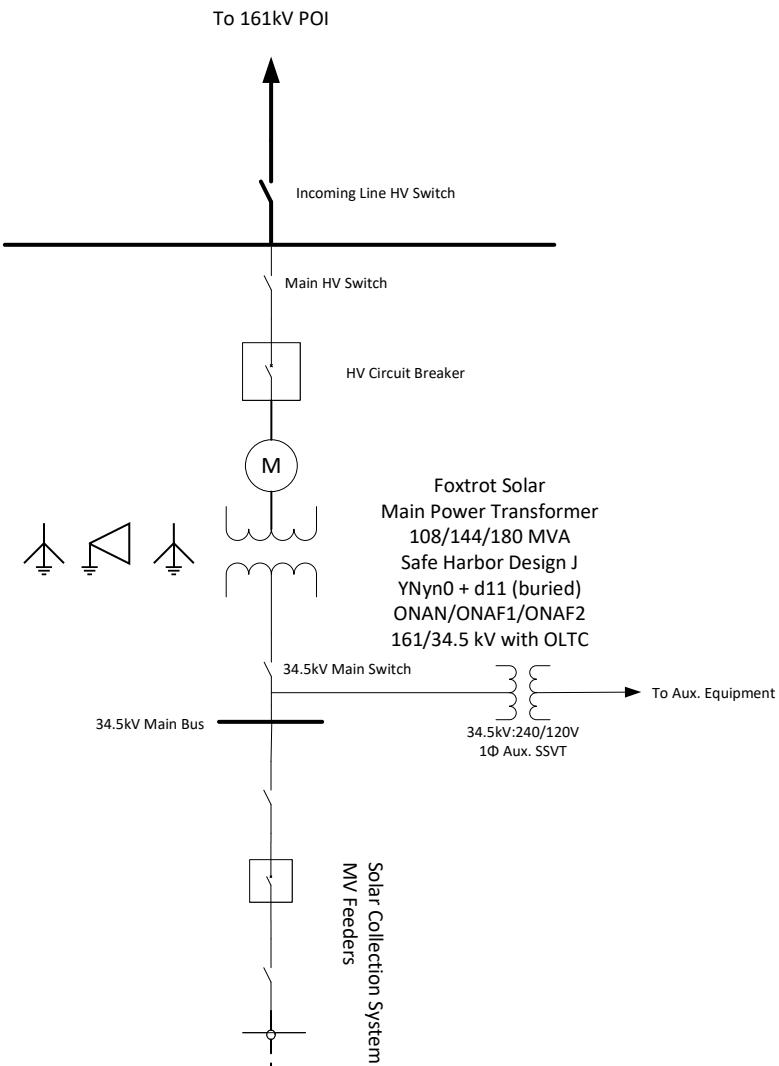

Legend	
	Fuse
	PV Array
	1500V DC Solar Inverter
	Transformer
	Circuit Breaker
	Switch
	Meter

Cable Legend	
	Underground (MV)
	Overhead (MV)

PRELIMINARY
NOT FOR CONSTRUCTION

Notes:
1.- Number of collection feeders TBD with Geotech studies

Created by: Kishore Nathan

Reviewed by: Ryan Weiper

Revision Date: 12/19/23

Sheet Name:
Foxtrot Solar
ONE-LINE DIAGRAM

SHT 1 OF 1
Rev A **Schedule JC-1b**

Page 1 of 1