

PERSIMMON CREEK
WIND PROJECT
WOODWARD COUNTY

| Rev. | Date | Description | By |
|------|----------|-------------------------|-----|
| A | 03-31-17 | 30% DESIGN SUBMITTAL | JEP |
| B | 09-15-17 | 60% DESIGN SUBMITTAL | JEP |
| C | 01-31-18 | 90% DESIGN SUBMITTAL | IJO |
| 0 | 03-02-18 | ISSUED FOR CONSTRUCTION | IJO |
| 1 | 07-11-18 | RECORD DRAWING | IJO |




LEGEND

- 345KV PROPOSED TRANSMISSION LINE
- EXISTING SOUTHERN STAR UNDERGROUND PIPELINE
- EXISTING WETLANDS
- EXCEPTION/NON-PARTICIPATING PROPERTY
- WIND TURBINE

RECORD DRAWING
DRAWINGS ARE BASED UPON CONSTRUCTION CONTRACTOR REDLINES WHICH HAVE NOT BEEN FIELD VERIFIED BY ENGINEER OF RECORD.



Ulteig
We listen. We solve.SM
3350 38th Avenue South
Fargo, North Dakota 58104
Phone: 701.280.8500
Fax: 701.237.3191
www.ulteig.com
Bismarck - Denver - Detroit Lakes - Fargo - Sioux Falls - St. Paul
Oklahoma Firm License: 5556
Design By: IJO
Drawn By: JMM
Approved By: BKF
Project Number: 16.01958






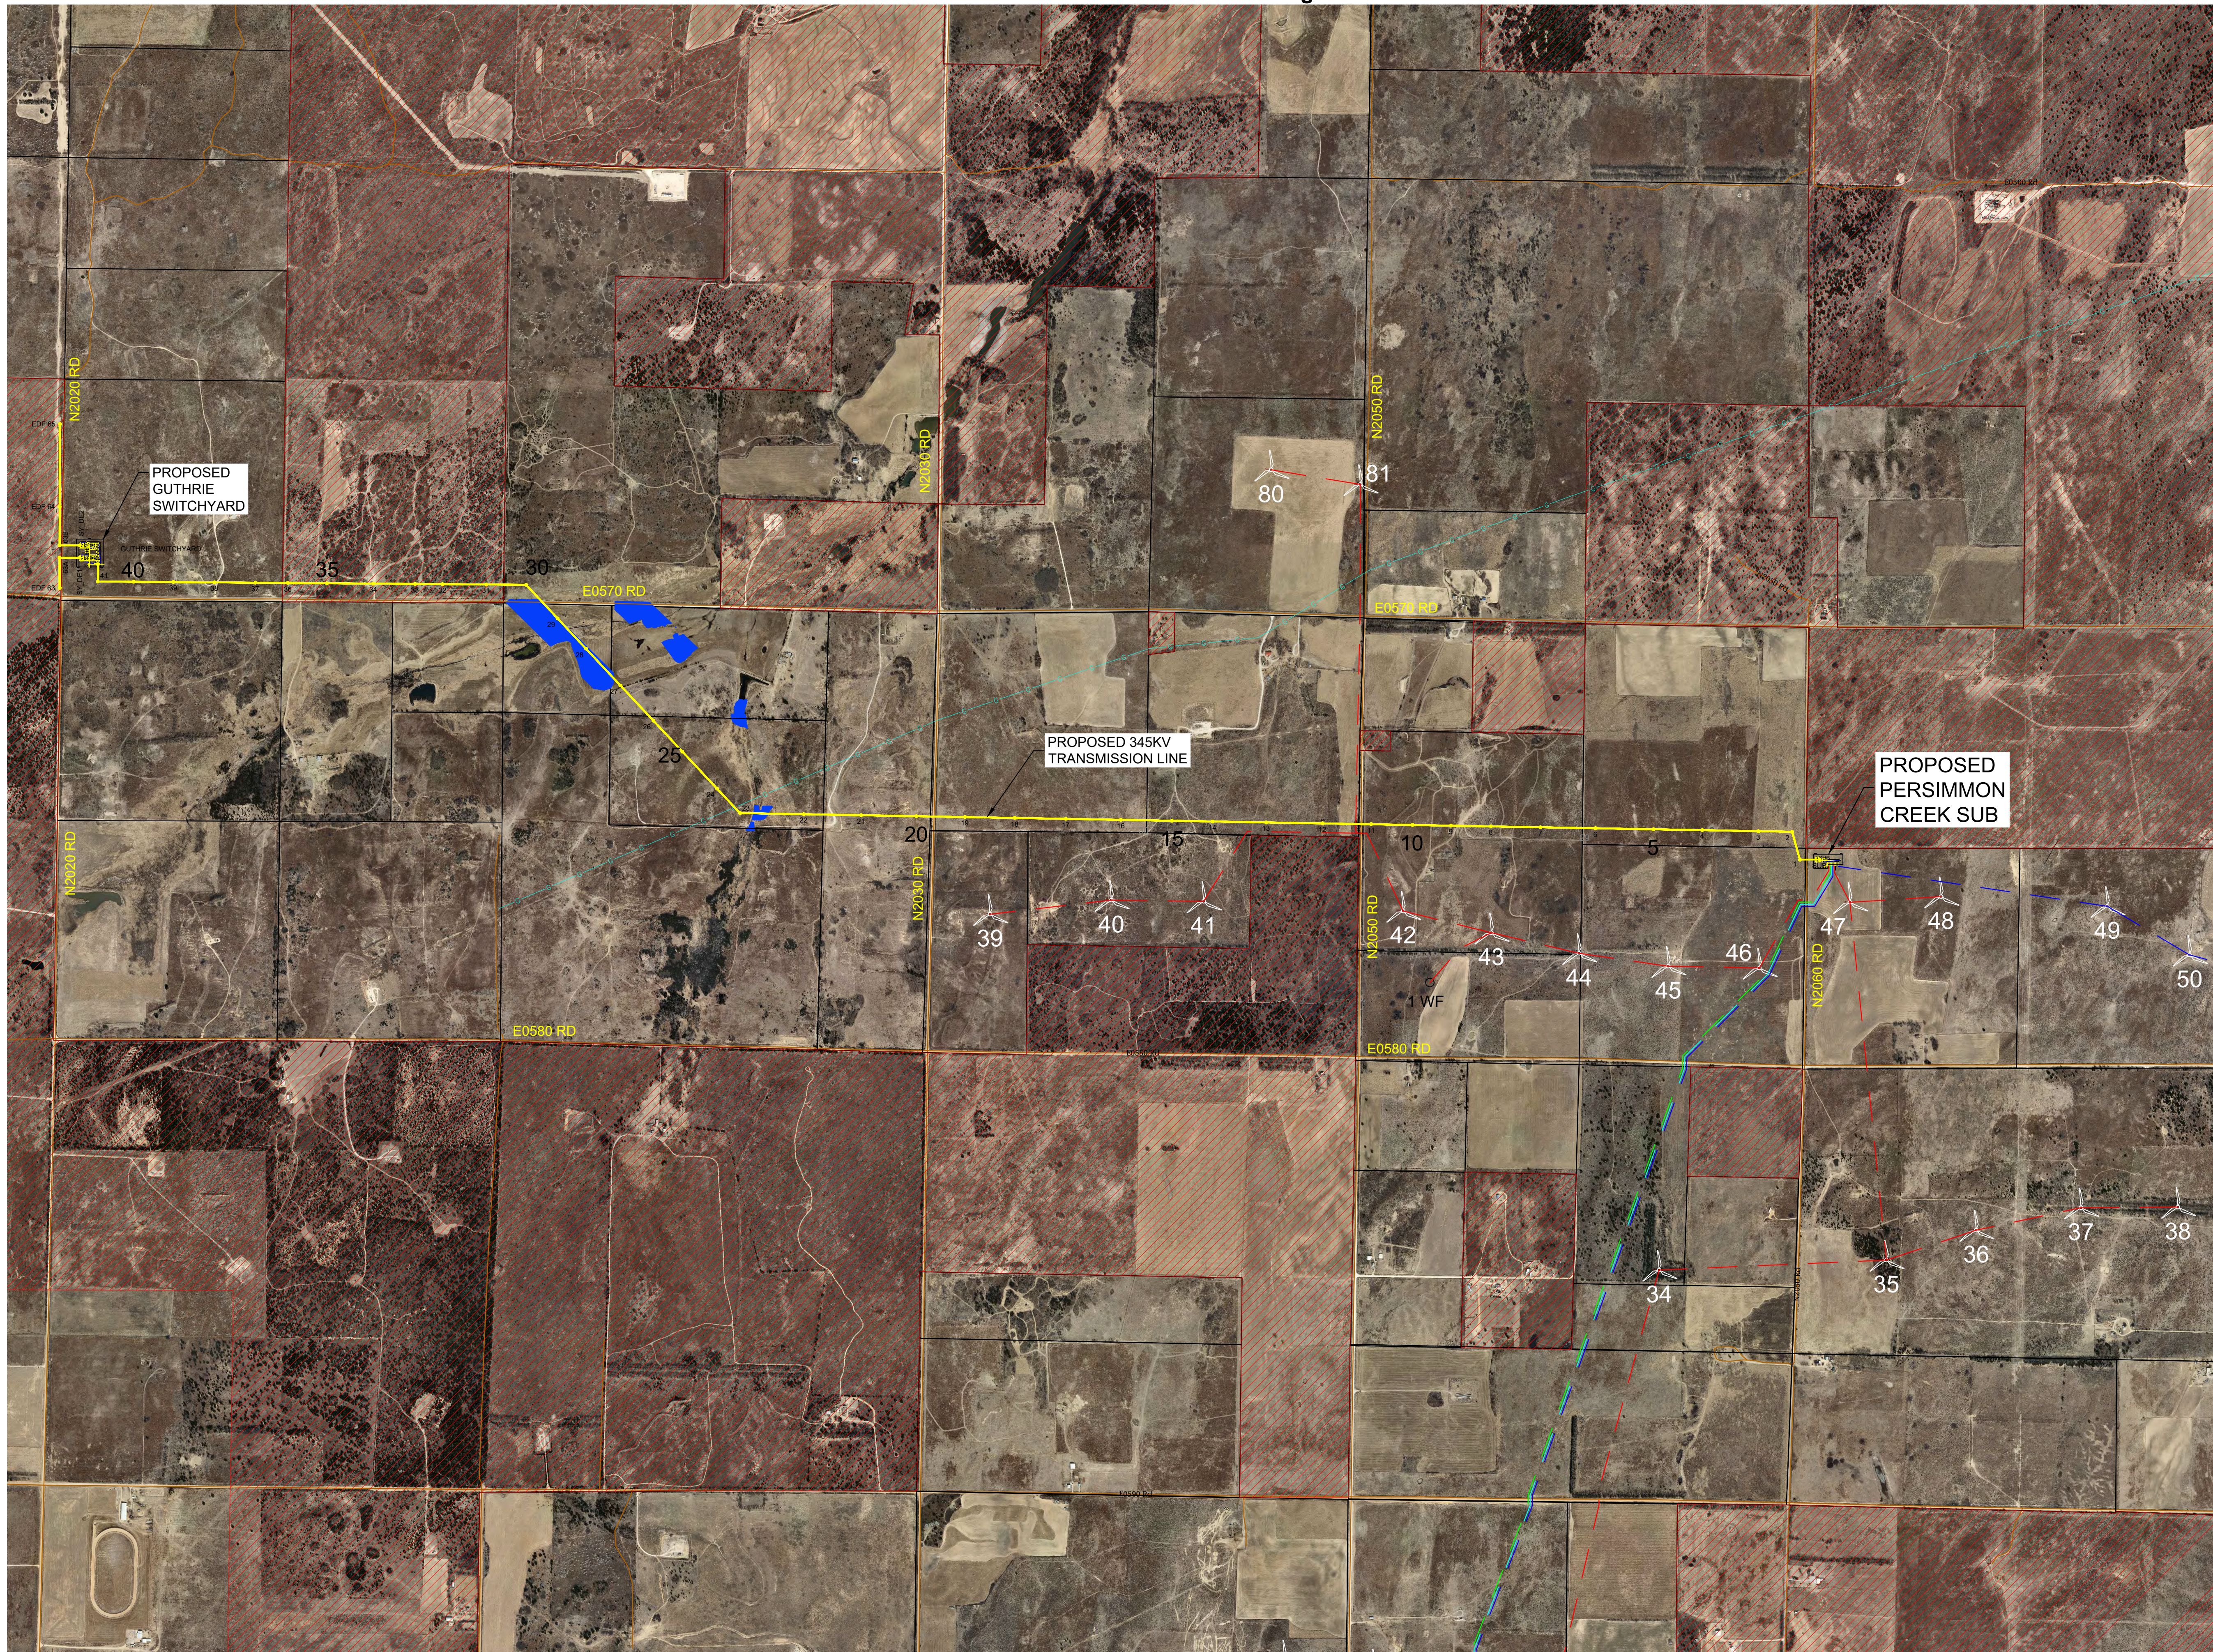


345KV TRANSMISSION LINE
ROUTE MAP

PERSIMMON CREEK 345kV TRANSMISSION LINE PHASING DIAGRAM

PERSIMMON CREEK
WIND PROJECT
OKLAHOMA

| Rev. | Date | Description | By |
|------|----------|-------------------------|-----|
| A | 01-31-18 | 90% DESIGN SUBMITTAL | IJO |
| 0 | 03-02-18 | ISSUED FOR CONSTRUCTION | IJO |
| 1 | 03-23-18 | ISSUED FOR CONSTRUCTION | IJO |
| 2 | 07-11-18 | RECORD DRAWING | IJO |

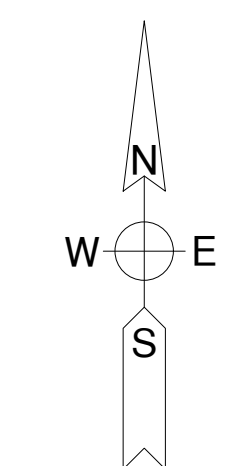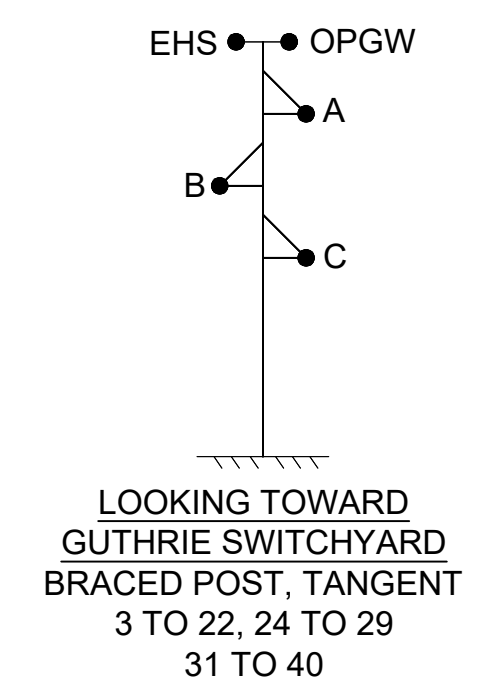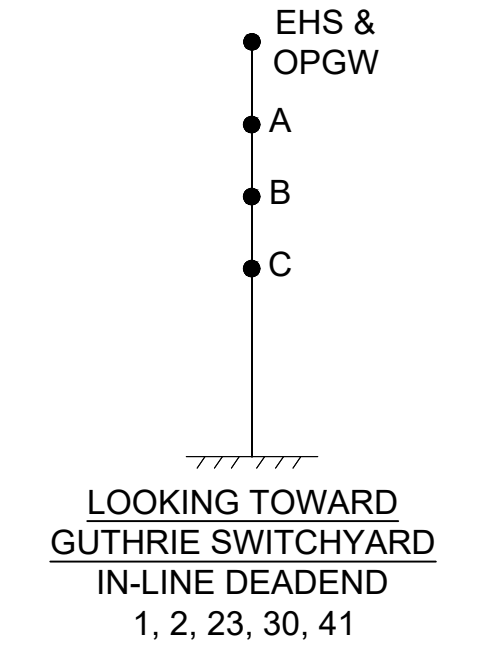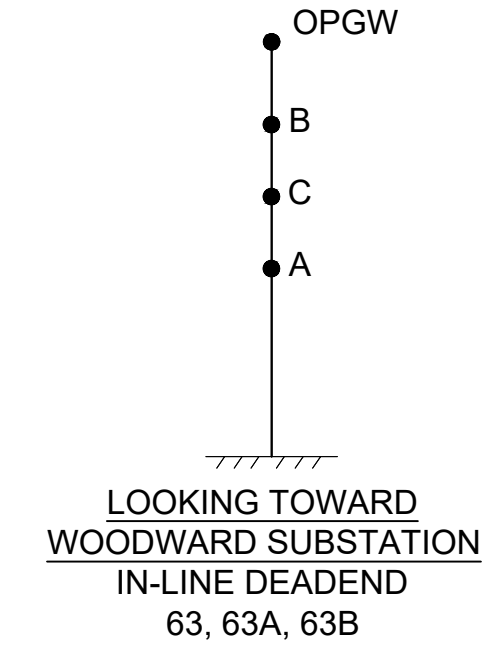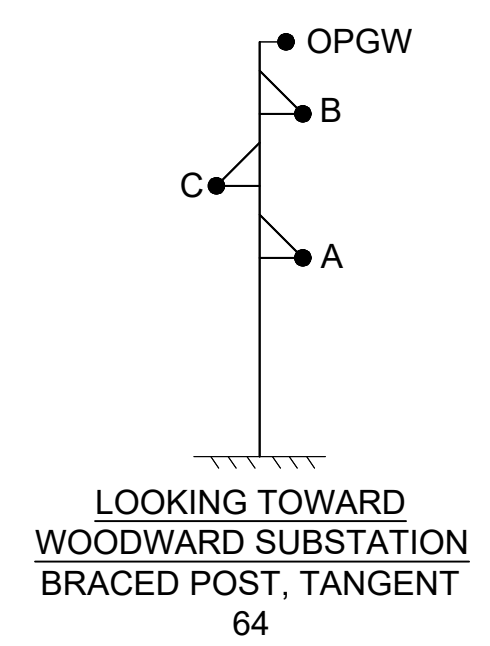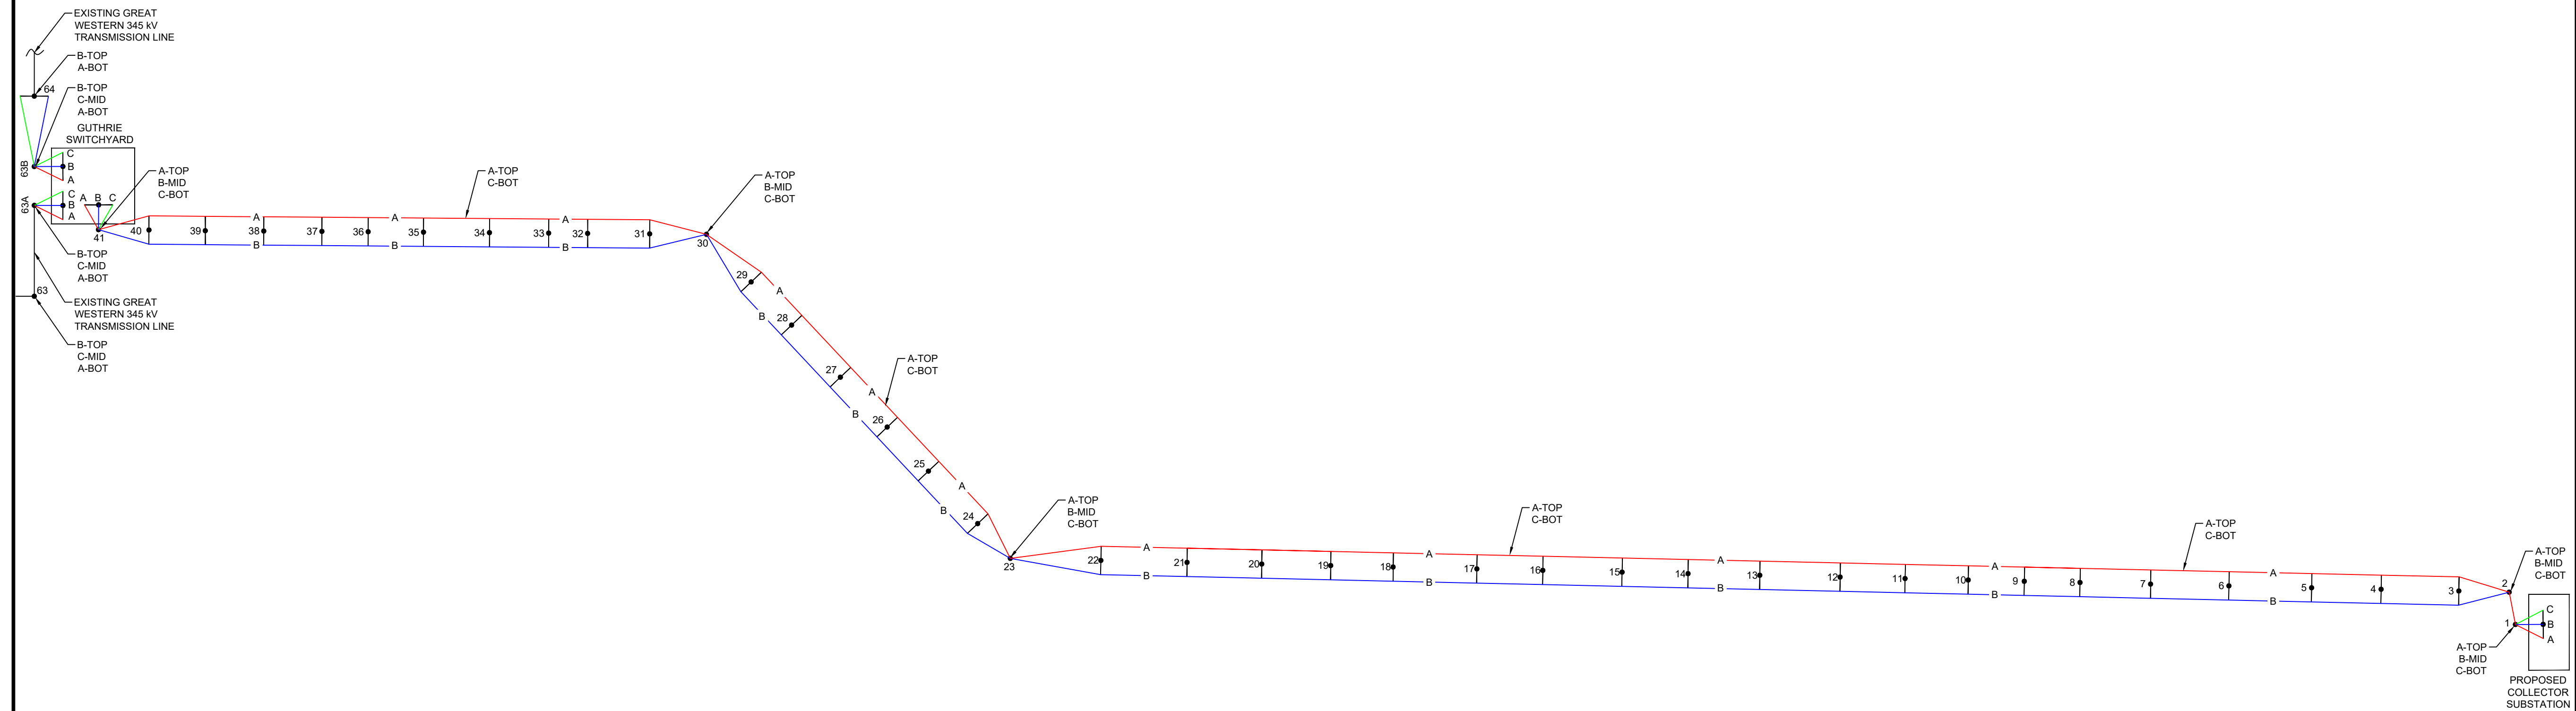

LEGEND

- PHASE A
- PHASE B
- PHASE C


NOTES (EDF STRUCTURES ONLY):

- CONDUCTOR: 795 KCMIL 26/7 ACSR "DRAKE"
- SHIELD WIRES: OPGW - AFL DNO-10926
- PLAN & PROFILES: SEE PCW-TRN-PP8 AND PCW-TRN-PP9 FOR PLAN & PROFILE.

NOTES:

- CONDUCTOR: 795 KCMIL 26/7 ACSR "DRAKE"
- SHIELD WIRES: OPGW - SFSJ-J-10918, & EHS - 3/8" 7 STRAND EHS
- PLAN & PROFILES: SEE PCW-TRN-PP1 THROUGH PCW-TRN-PP7 FOR PLAN & PROFILE.
- LINE LENGTH = 4.25 MILES

RECORD DRAWING
DRAWINGS ARE BASED UPON CONSTRUCTION CONTRACTOR REDLINES WHICH HAVE NOT BEEN FIELD VERIFIED BY ENGINEER OF RECORD.

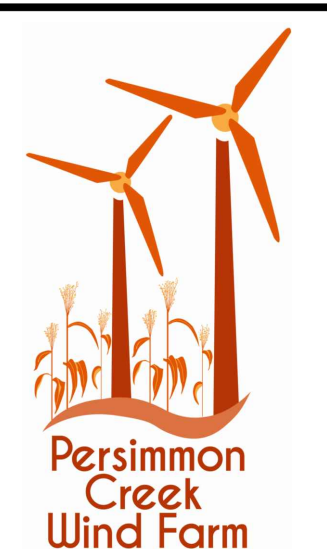



Ulteig
3350 38th Avenue South
Fargo, North Dakota 58104
Phone: 701.280.8500
Fax: 701.237.3191
www.ulteig.com

We listen. We solve.™
Bismarck - Denver - Detroit Lakes - Fargo - Sioux Falls - St. Paul
Oklahoma Firm License: 5556

Design By: IJO
Drawn By: GJP
Approved By: BKF
Project Number: 16.01958


TRANSMISSION LINE PHASING DIAGRAM

DWG #: PCW-TRN-002 REVISION: 2

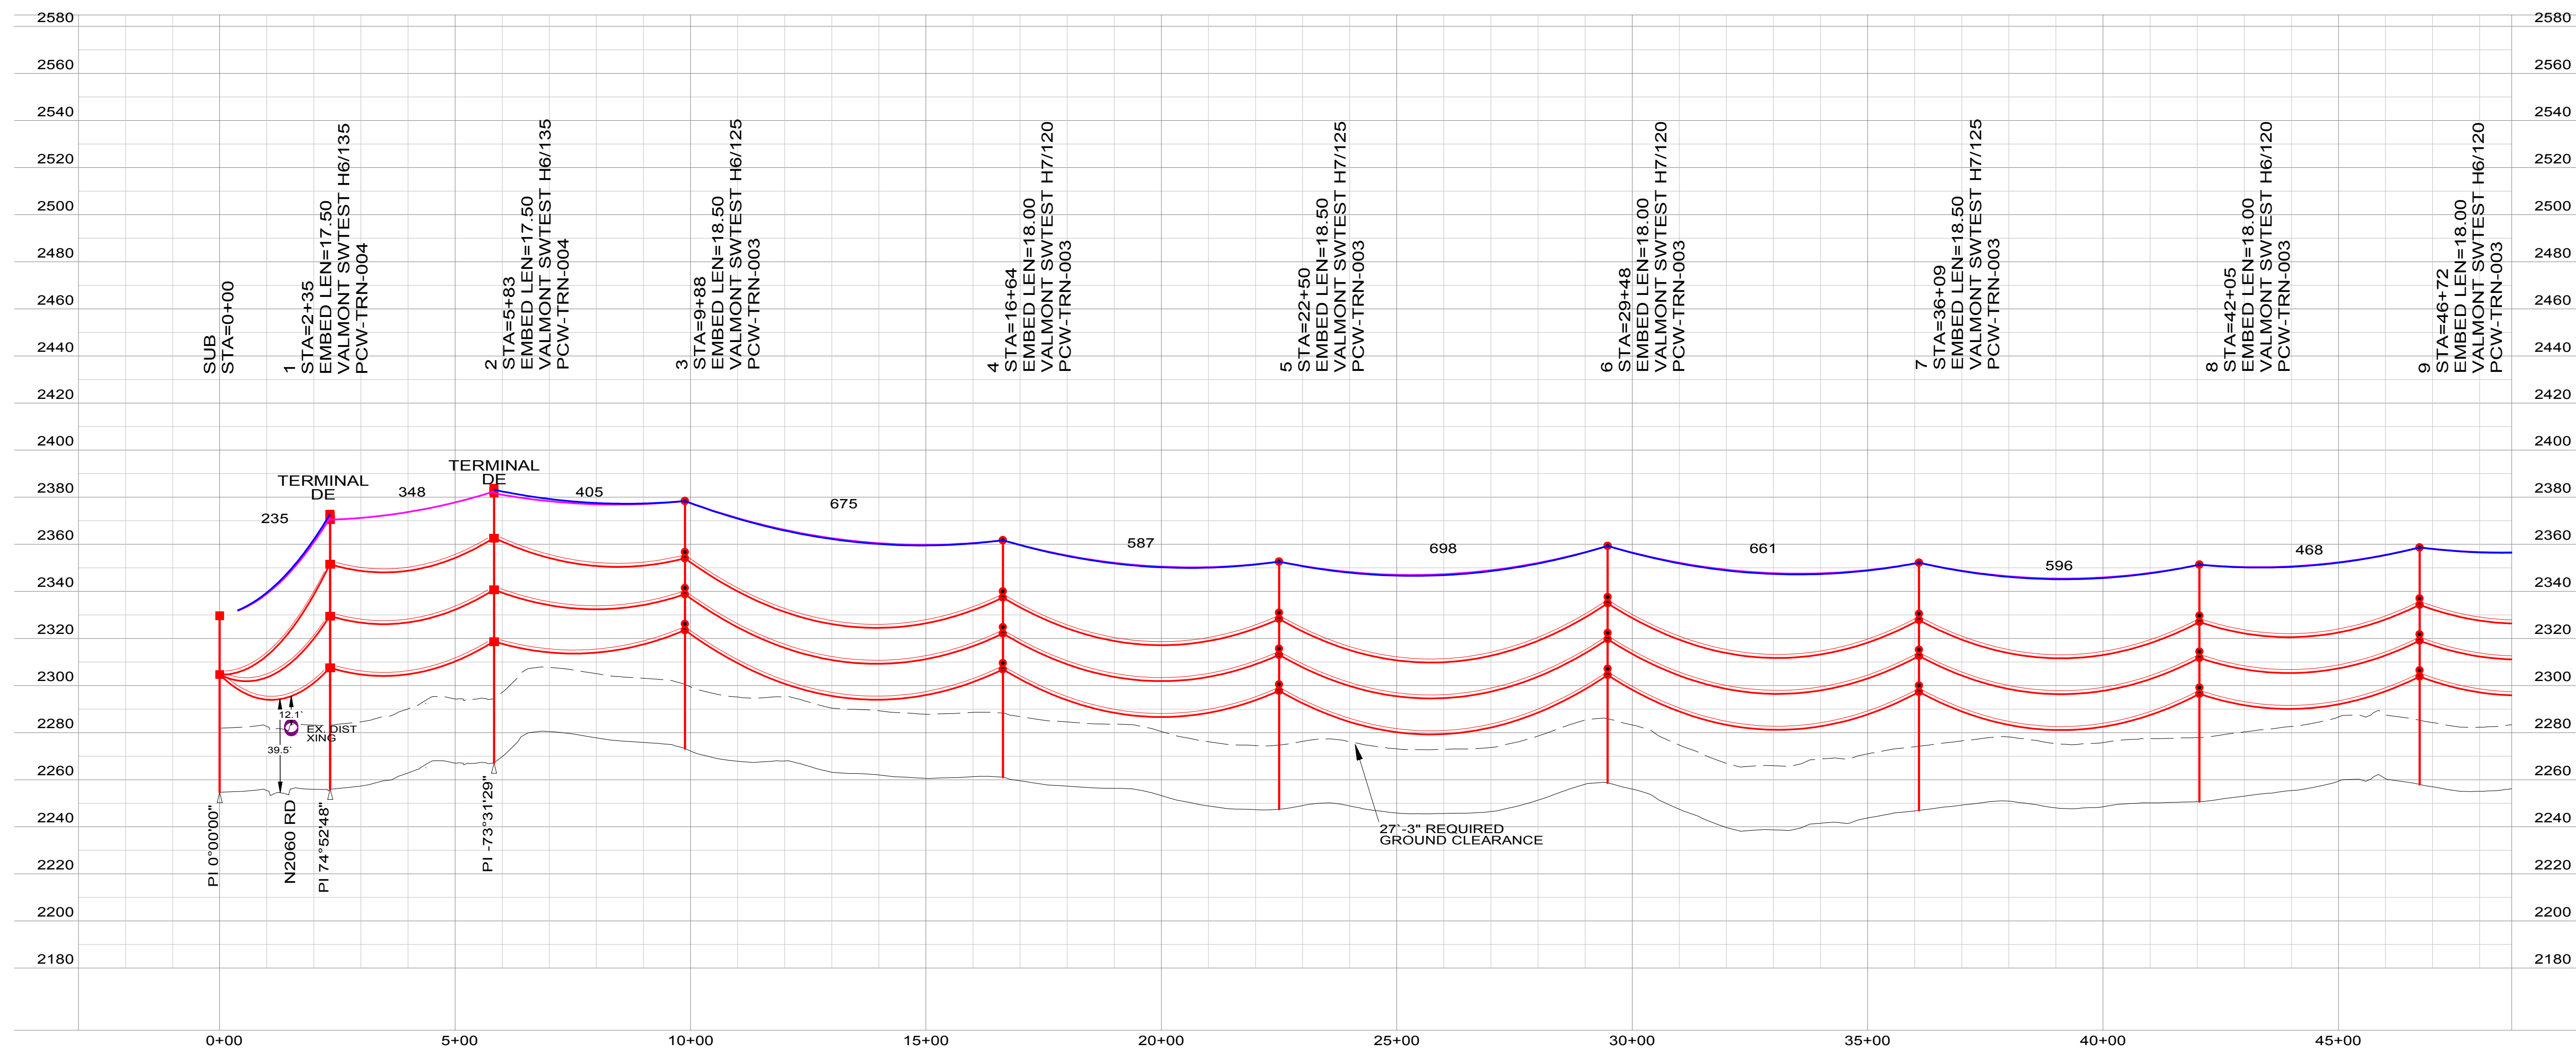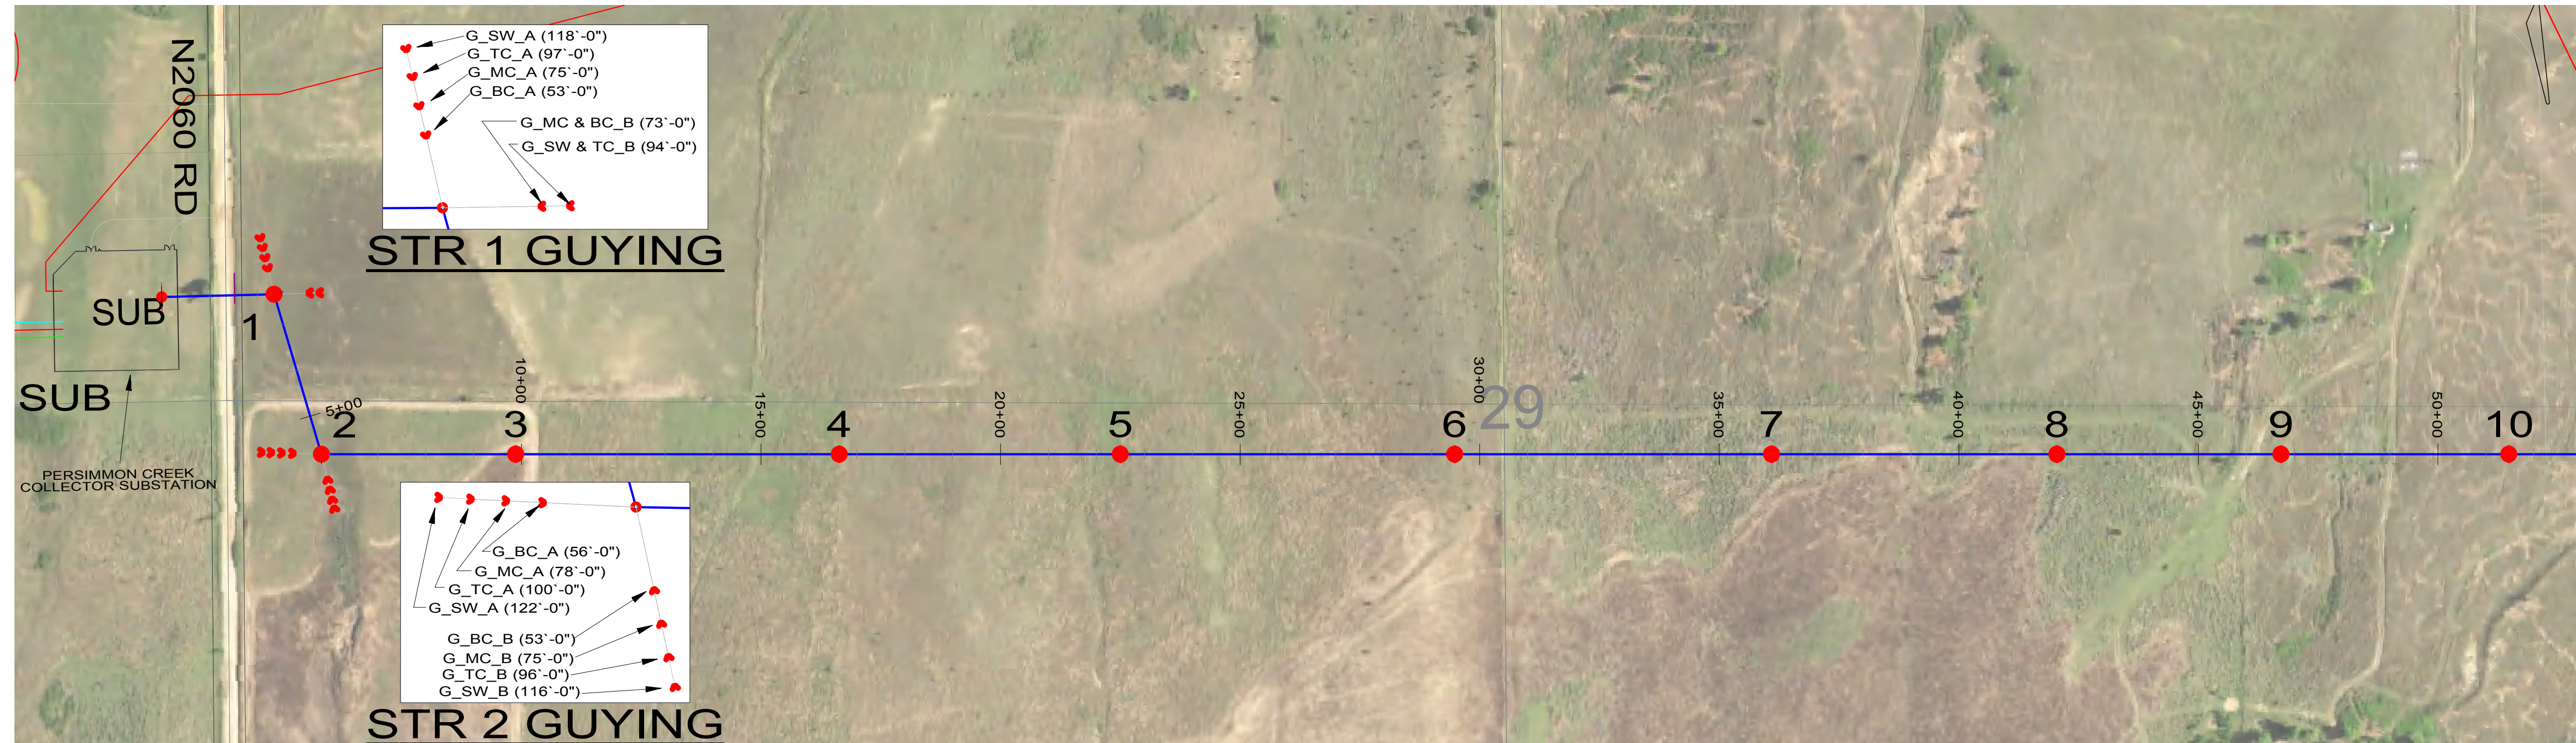

PERSIMMON CREEK WIND PROJECT
OKLAHOMA WOODWARD COUNTY

| REV. | DATE | DESCRIPTION | BY |
|------|----------|-------------------|-----|
| A | 03/31/17 | 30% DESIGN | JEP |
| B | 09/18/17 | 60% DESIGN | IJO |
| C | 01/31/18 | 90% DESIGN | IJO |
| 0 | 03/02/18 | ISSUED FOR CONST. | IJO |
| 1 | 07/11/18 | ISSUED FOR RECORD | IJO |

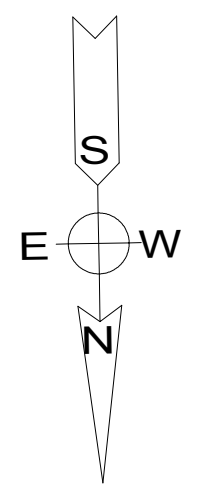

RECORD DRAWING
DRAWINGS ARE BASED UPON CONSTRUCTION CONTRACTOR REDLINES WHICH HAVE NOT BEEN FIELD VERIFIED BY ENGINEER OF RECORD




Ulteig
3350 38TH AVENUE SOUTH
FARGO, NORTH DAKOTA 58104
PHONE: 701.280.8500
FAX: 701.237.3191
WWW.ULTEIG.COM

OKLAHOMA FIRM LICENSE: 5556
DESIGN BY: IJO
DRAWN BY: JEP
APPROVED BY: BKF
PROJECT NUMBER: 16.01958



345KV TRANSMISSION LINE PLAN AND PROFILE

STR SUB TO STR 9
DWG #: PCW-TRN-PP2
REVISION: 1

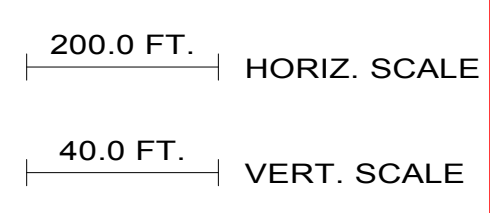


PERSIMMON CREEK WIND PROJECT
OKLAHOMA
WOODWARD COUNTY

| REV. | DATE | DESCRIPTION | BY |
|------|----------|-------------------|-----|
| A | 03/31/17 | 30% DESIGN | JEP |
| B | 09/18/17 | 60% DESIGN | IJO |
| C | 01/31/18 | 90% DESIGN | IJO |
| 0 | 03/02/18 | ISSUED FOR CONST. | IJO |
| 1 | 07/11/18 | ISSUED FOR RECORD | IJO |

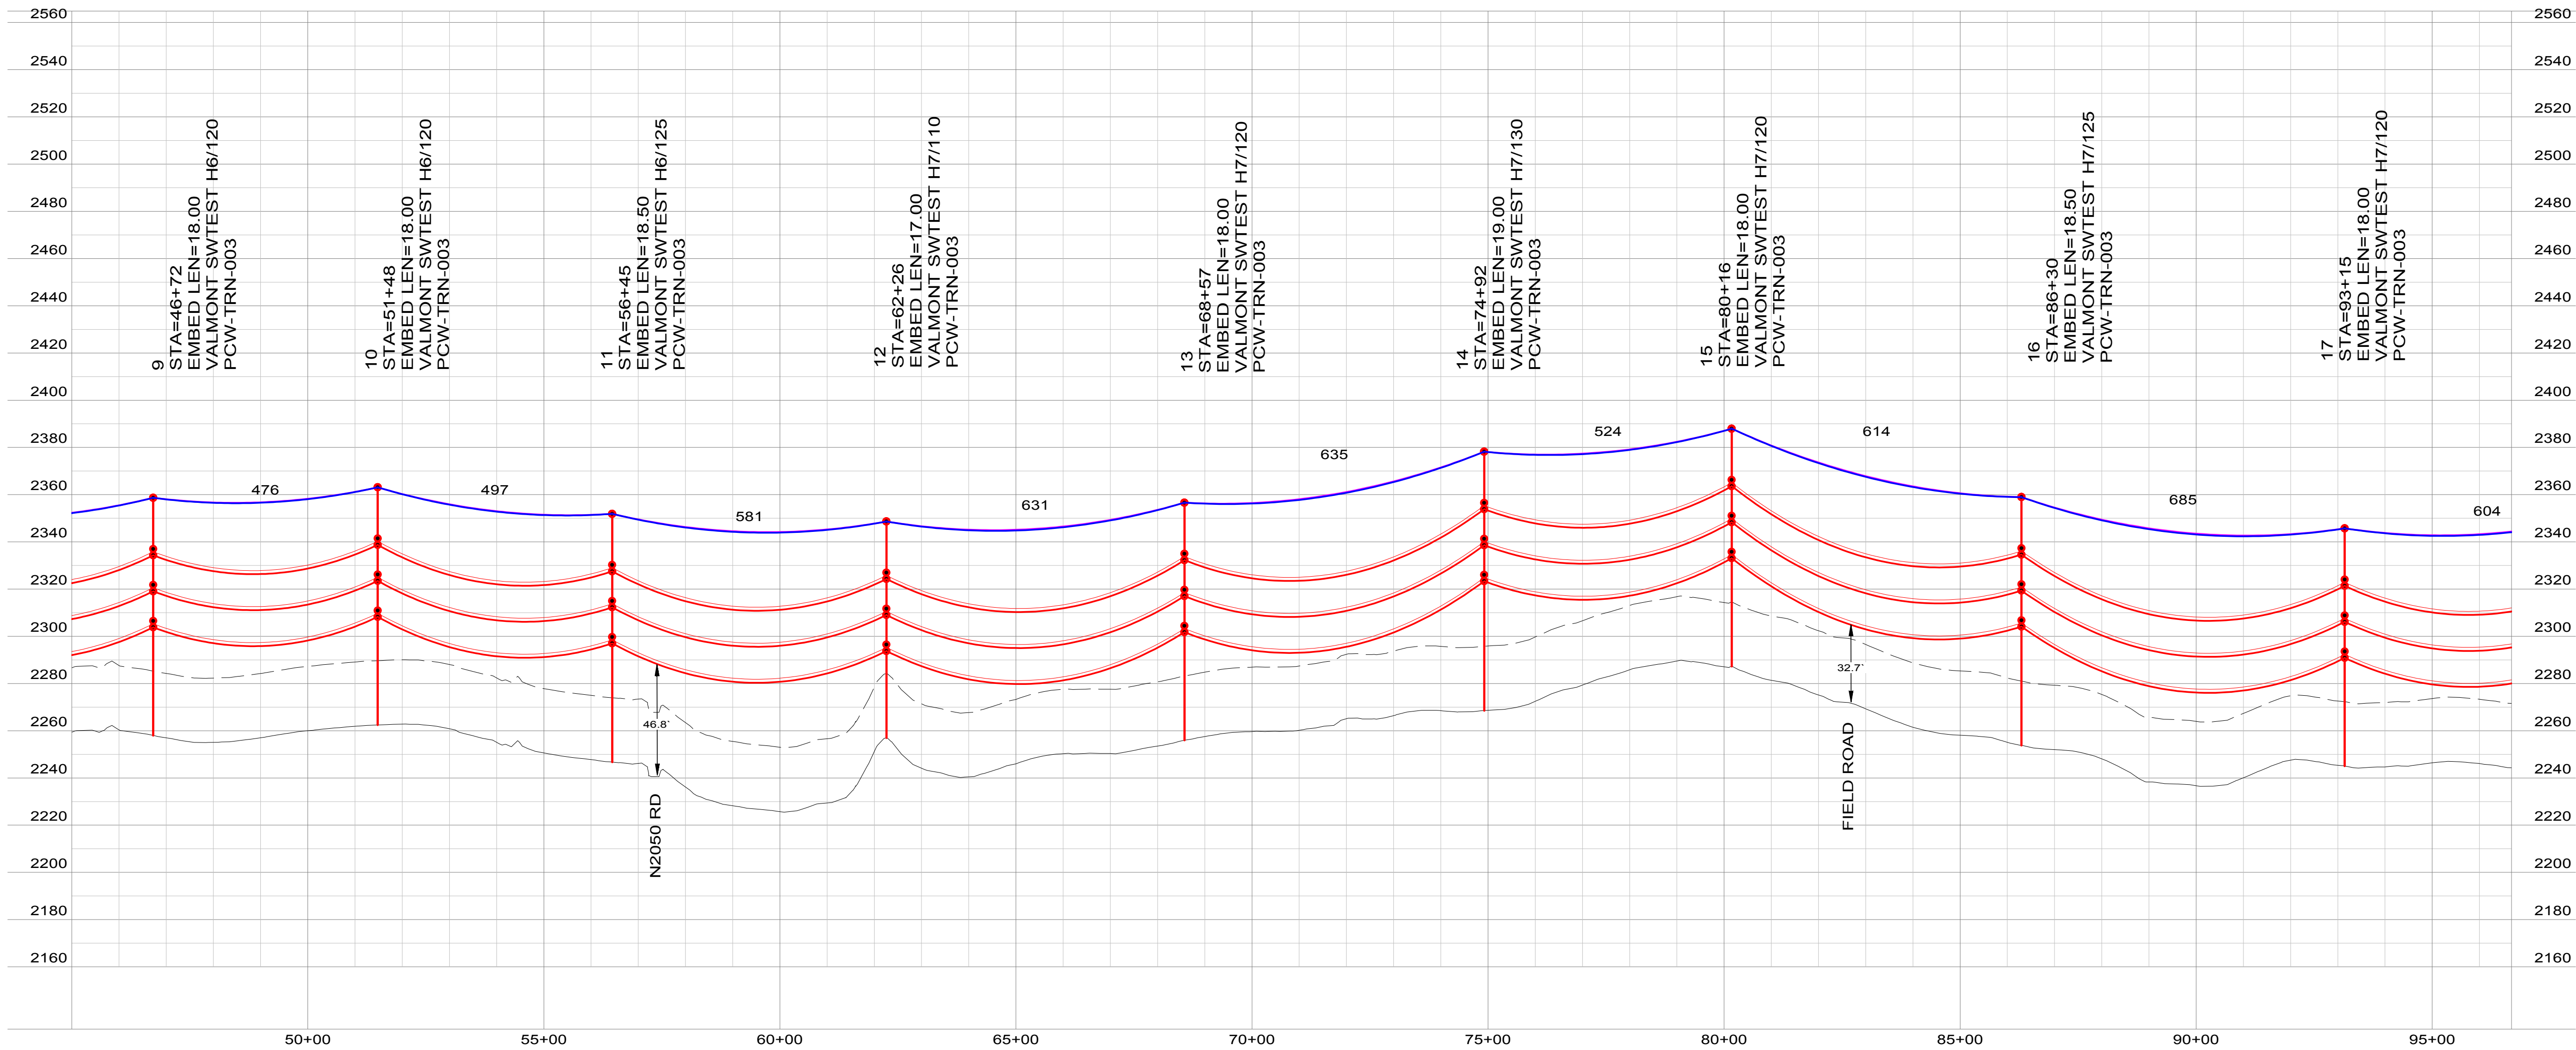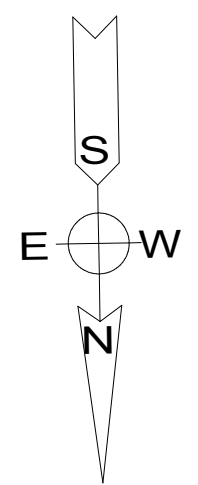

200.0 FT. HORIZ. SCALE
40.0 FT. VERT. SCALE

RECORD DRAWING
DRAWINGS ARE BASED UPON CONSTRUCTION CONTRACTOR REDLINES WHICH HAVE NOT BEEN FIELD VERIFIED BY ENGINEER OF RECORD

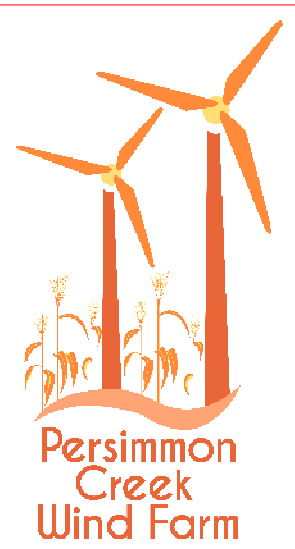

Ulteig
3350 38TH AVENUE SOUTH
FARGO, NORTH DAKOTA 58104
PHONE: 701.280.8500
FAX: 701.237.3191
WWW.ULTEIG.COM




OKLAHOMA FIRM LICENSE: 5556
DESIGN BY: IJO
DRAWN BY: JEP
APPROVED BY: BKF
PROJECT NUMBER: 16.01958

345KV
TRANSMISSION LINE
PLAN AND PROFILE


STR 9 TO STR 17
DWG #: PCW-TRN-PP3
REVISION: 1

PERSIMMON CREEK WIND PROJECT
OKLAHOMA WOODWARD COUNTY

| REV. | DATE | DESCRIPTION | BY |
|------|----------|-------------------|-----|
| A | 03/31/17 | 30% DESIGN | JEP |
| B | 09/18/17 | 60% DESIGN | IJO |
| C | 01/31/18 | 90% DESIGN | IJO |
| 0 | 03/02/18 | ISSUED FOR CONST. | IJO |
| 1 | 07/11/18 | ISSUED FOR RECORD | IJO |

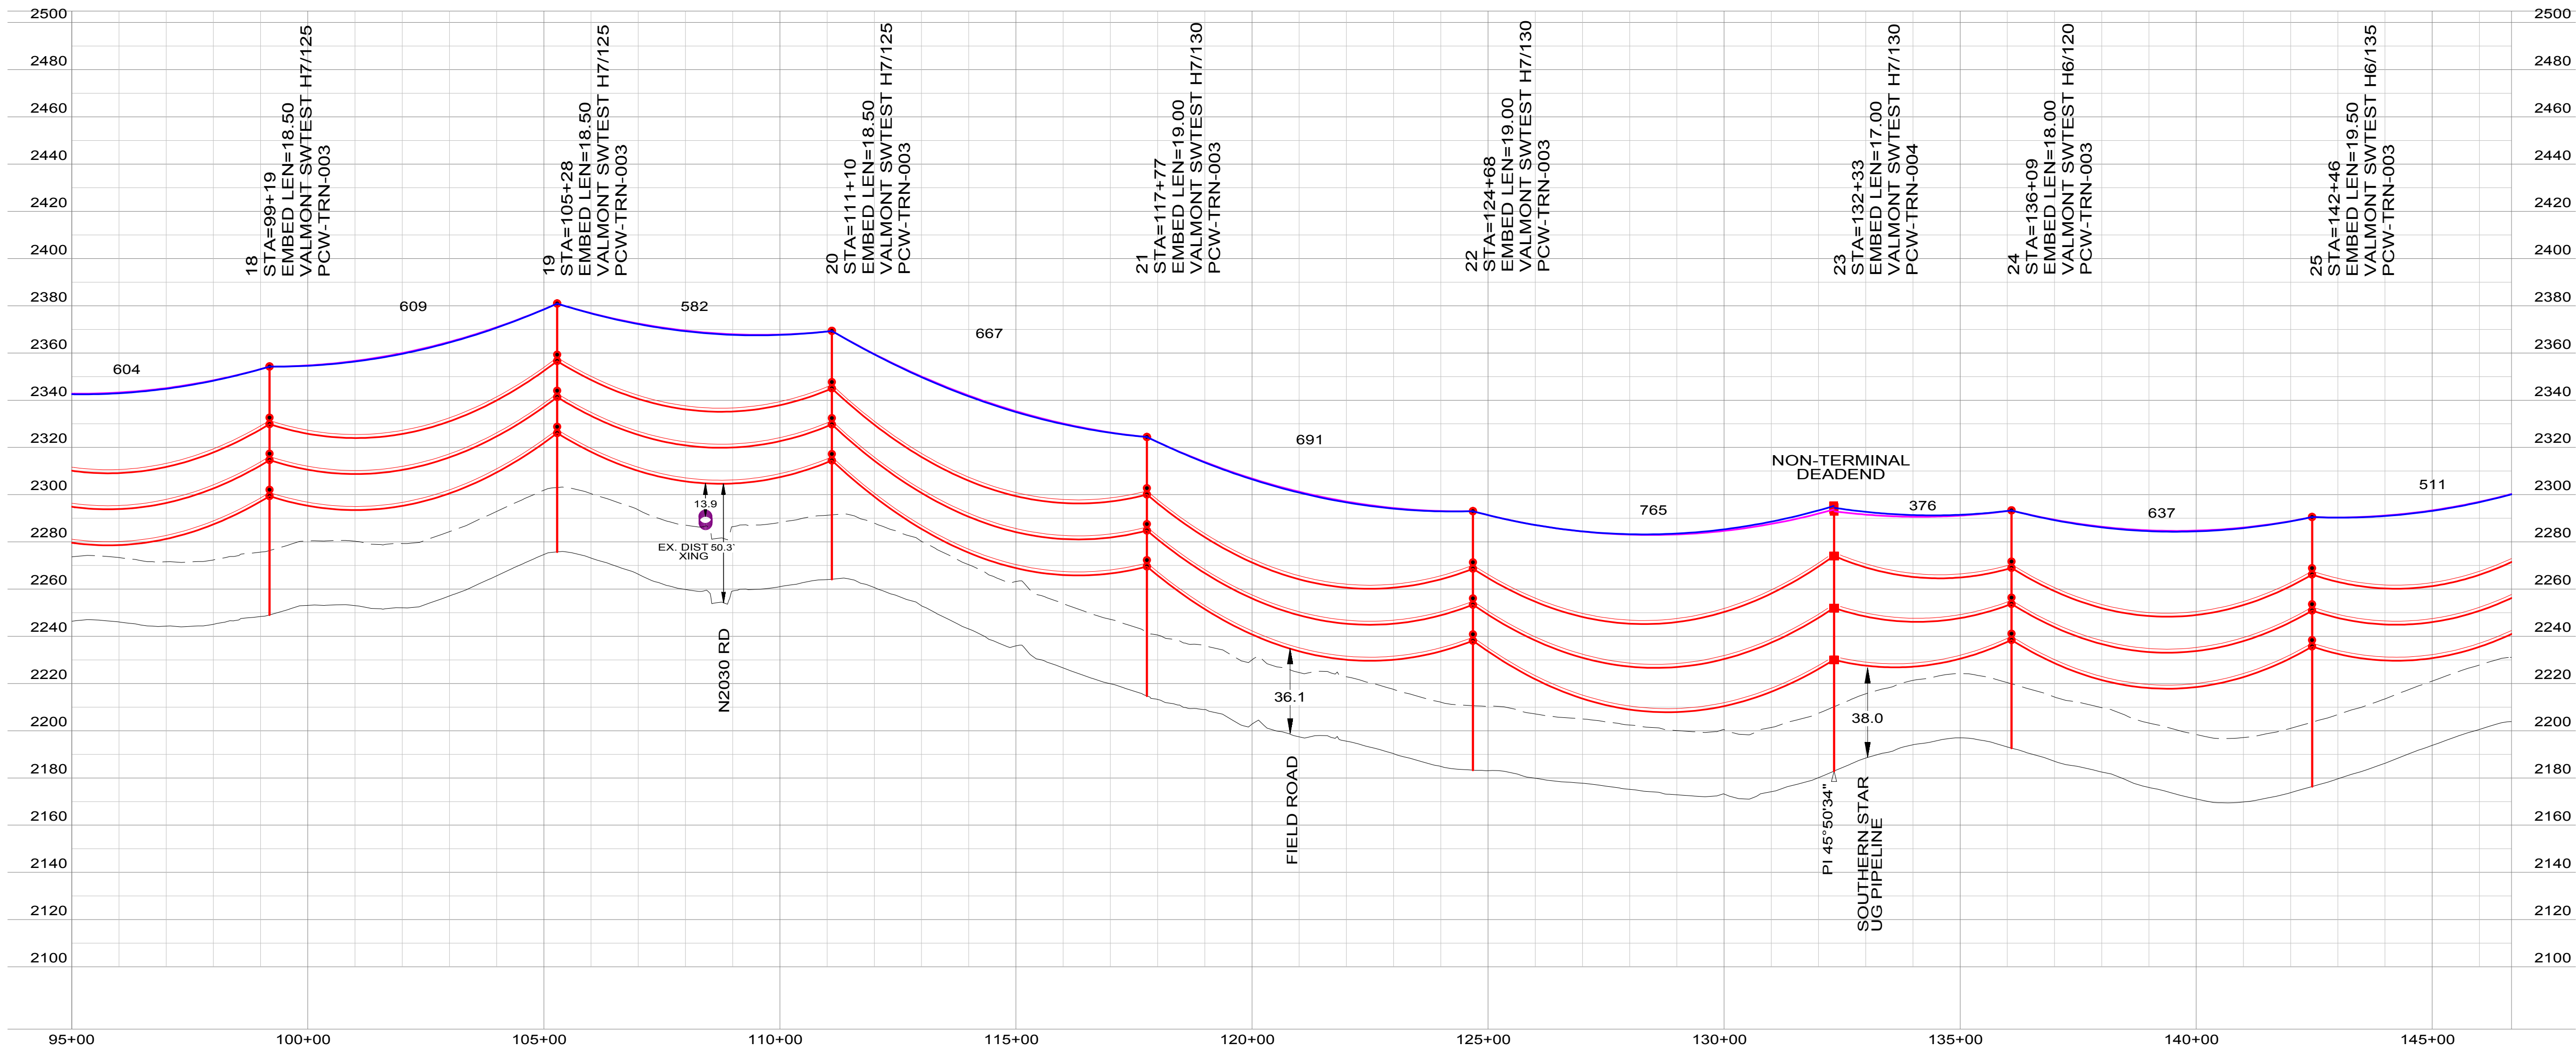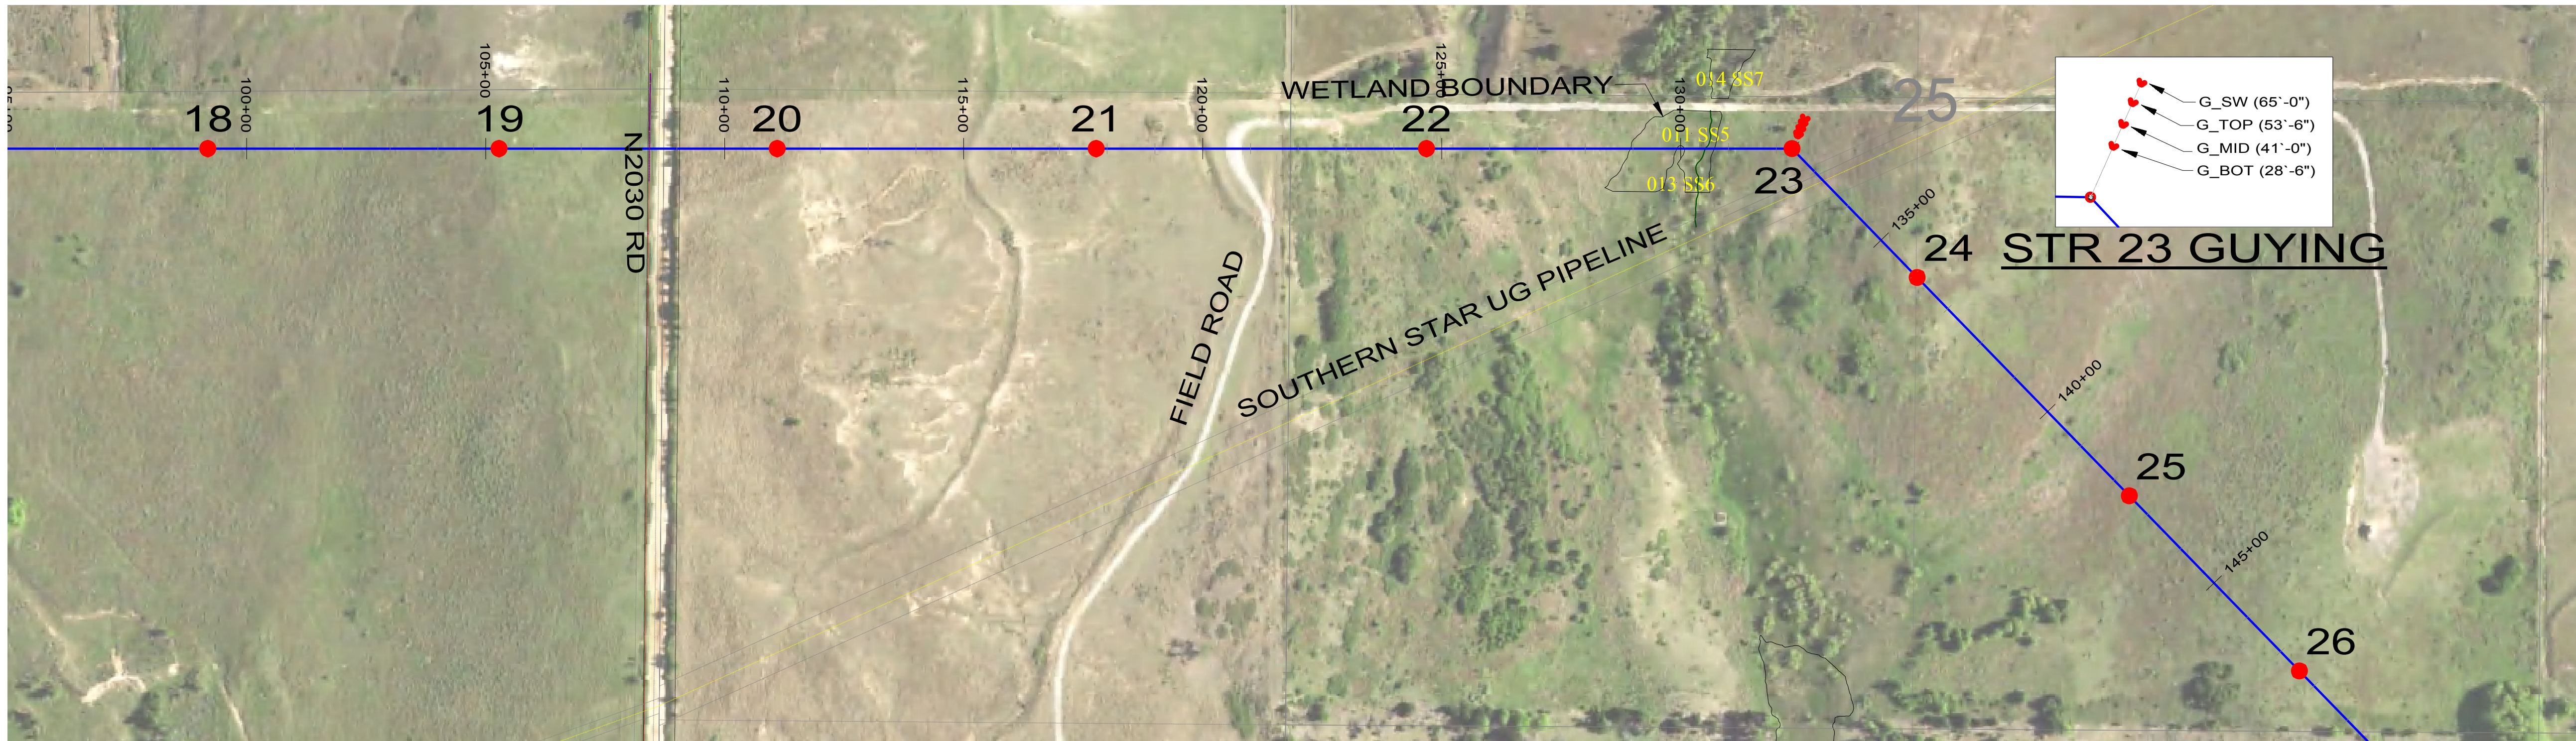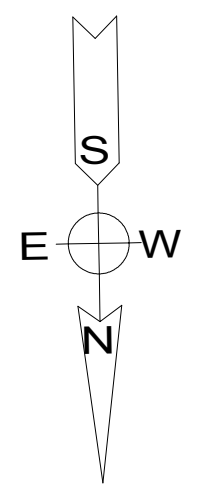

RECORD DRAWING
DRAWINGS ARE BASED UPON CONSTRUCTION CONTRACTOR REDLINES WHICH HAVE NOT BEEN FIELD VERIFIED BY ENGINEER OF RECORD

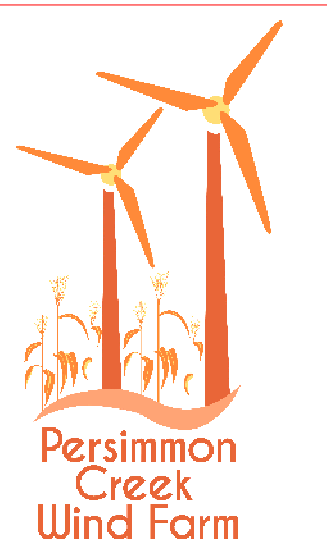

Ulteig
3350 38TH AVENUE SOUTH
FARGO, NORTH DAKOTA 58104
PHONE: 701.280.8500
FAX: 701.237.3191
WWW.ULTEIG.COM

We listen. We solve.™
BISMARCK - DENVER - DETROIT LAKES - FARGO - SIOUX FALLS - ST. PAUL
OKLAHOMA FIRM LICENSE: 5556
DESIGN BY: IJO
DRAWN BY: JEP
APPROVED BY: BKF
PROJECT NUMBER: 16.01958

345KV TRANSMISSION LINE PLAN AND PROFILE

STR 18 TO STR 25

DWG #: PCW-TRN-PP4 REVISION: 1

